


GENERATOR AT HWY 301 SITE PLAN – FUEL GAS
SCALE: 1/4"=1'-0" 1016.00

FUEL GAS GENERAL NOTES

- ALL PLUMBING WORK SHALL MEET ALL THE REQUIREMENTS OF THE "2020 FLORIDA FUEL GAS CODE, PLUMBING – 7TH EDITION"
- REVIEW PLANS OF ALL TRADES PRIOR TO BIDDING AND INSTALLATION TO INCLUDE ALL PLUMBING FOR COMPLETE SYSTEMS SHOWN ON THE PLANS AND AS REQUIRED.
- COORDINATE WITH OTHER TRADES TO PREVENT INTERFERENCE WITH OTHER TRADE WORK.
- ALL CHANGES SHALL BE APPROVED BY THE ENGINEER.
- COORDINATE WITH THEA AND ENGINEERING DRAWINGS BEFORE ROUGHING-IN.
- VERIFY LOCATION OF EXISTING GAS SERVICE AND THE LOCATION OF NEARBY UTILITIES PRIOR TO INSTALLATION.
- IT IS IN THE INTENT OF THESE DRAWINGS TO COVER ALL WORK AND MATERIAL. ANY EQUIPMENT, PLUMBING FIXTURE, TRIM HARDWARE AND/OR DEVICES USUALLY UTILIZED IN THE CLASS OF WORK, THOUGH NOT SPECIFICALLY MENTIONED OR SHOWN ON THESE DRAWINGS, BUT WHICH MAY BE NECESSARY FOR THE SATISFACTORY COMPLETION OF THE WORK (AS DETERMINED BY THE ENGINEER) SHALL BE FURNISHED AND INSTALLED BY THE CONTRACTOR AS PART OF HIS TOTAL WORK.
- ALL WORK, BOTH MATERIAL AND INSTALLATION, SHALL BE GUARANTEED FOR A PERIOD OF ONE YEAR FROM DATE OF ACCEPTANCE BY THE OWNER.
- ABOVE GROUND GAS PIPING SHALL BE SCHEDULE 40 BLACK STEEL. EXPOSED PIPING SHALL BE PAINTED YELLOW WITH (2) COATS OF A CORROSION INHIBITING PAINT.
- CONNECTIONS OF PIPING WITH DISSIMILAR METALS SHALL HAVE THE PROPER DIALECTIC FITTINGS TO INHIBIT CORROSION.

FUEL GAS LEGEND

DESCRIPTION	ABBREV.	SYMBOL
NEW GAS PIPING	G	—
GAS COCK	GC	— —
EXISTING GAS PIPING	G	- - -

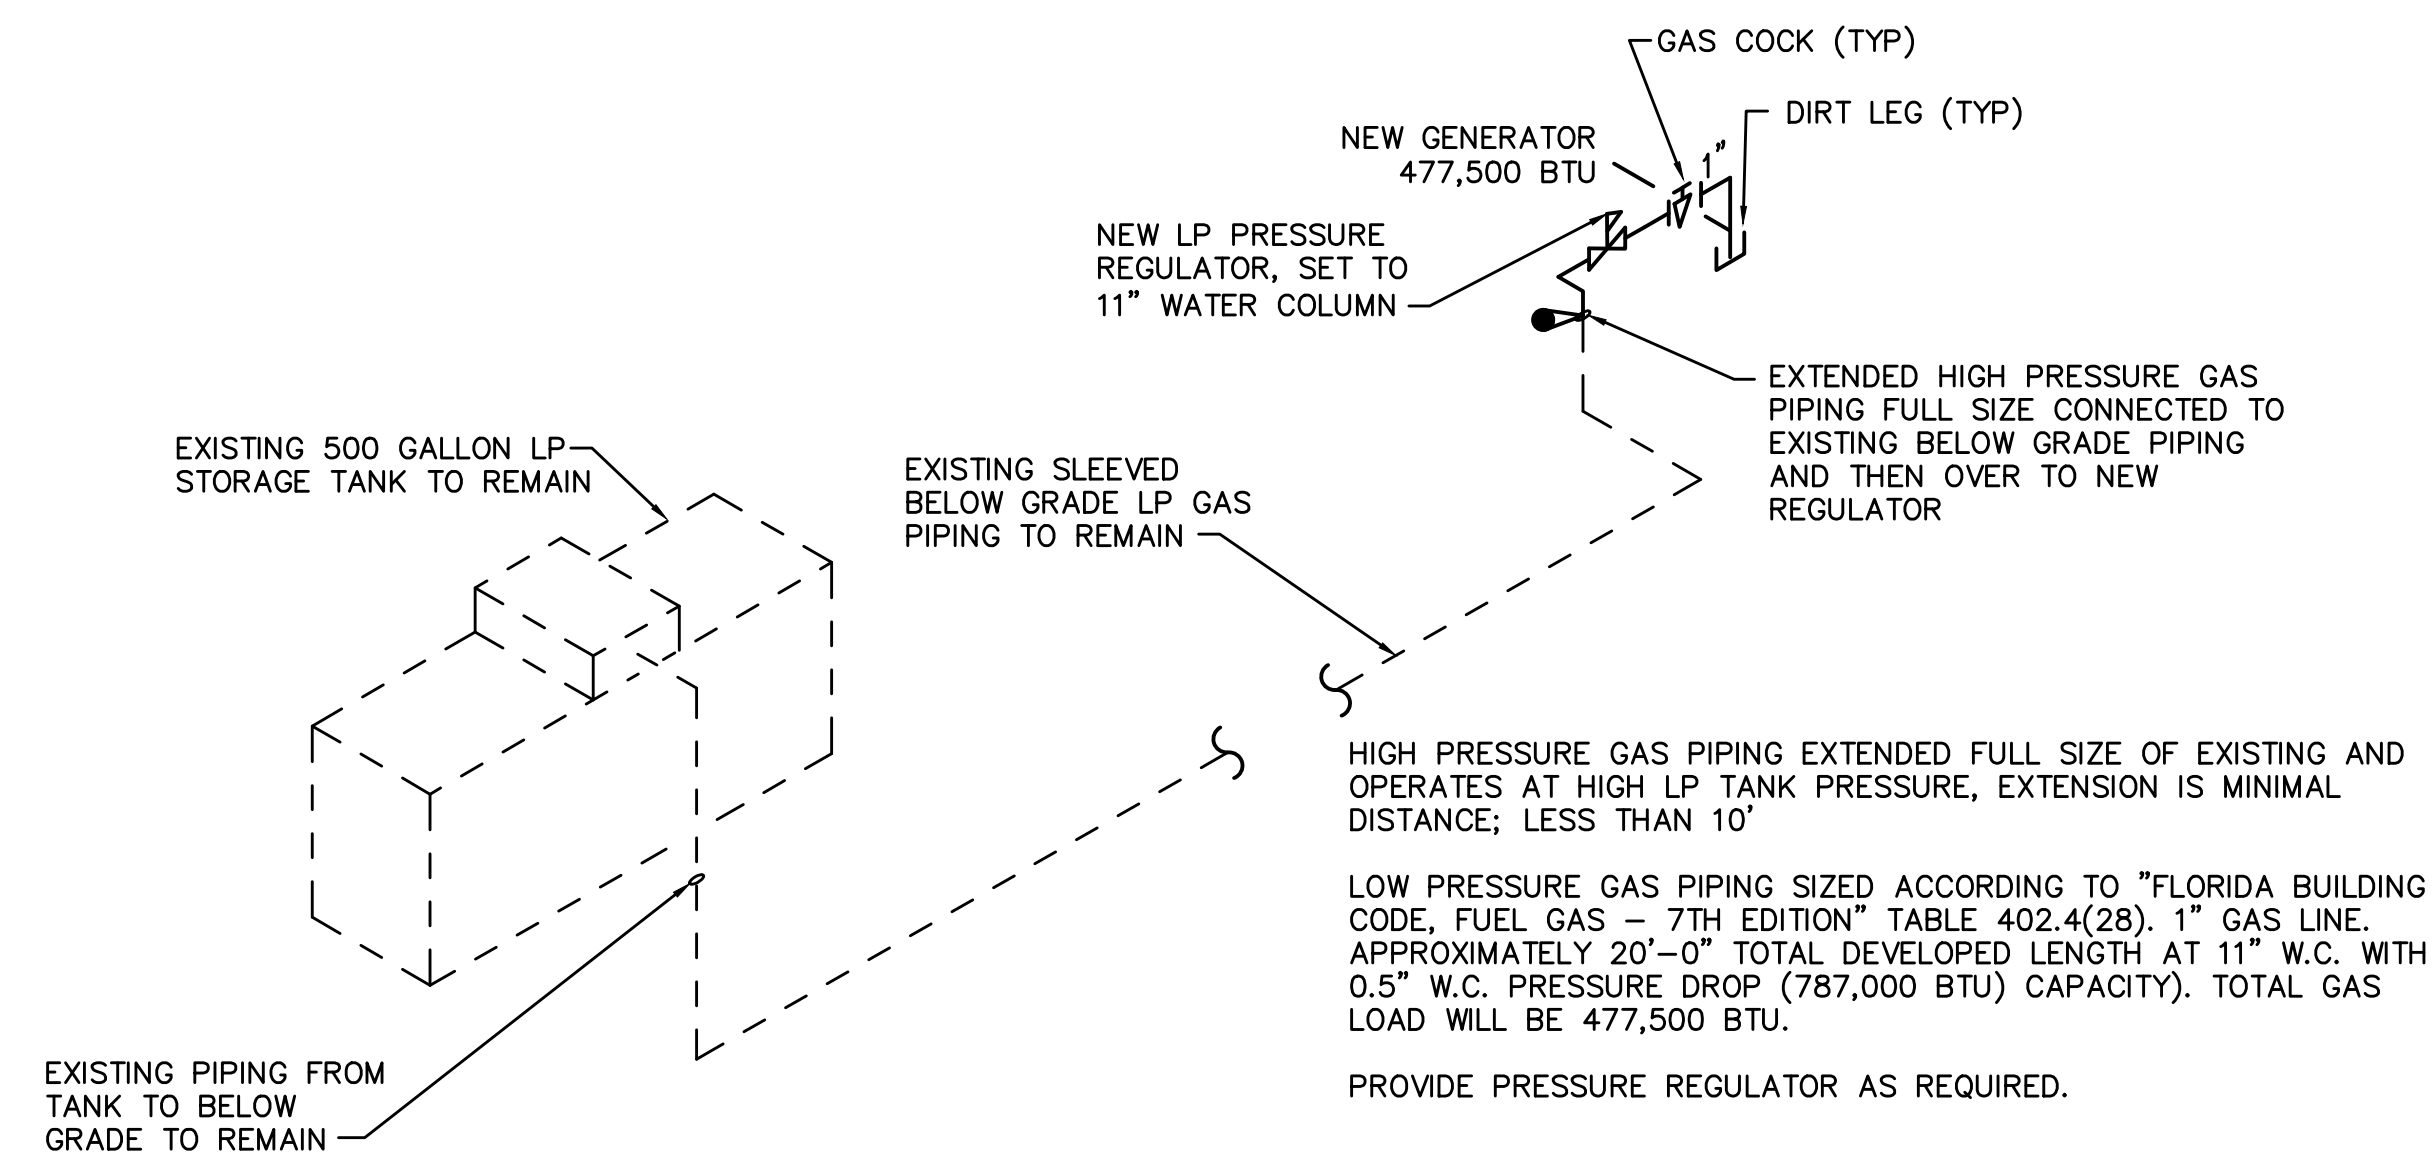

GAS RISER DIAGRAM
NTS

Issue / Revision:	No.	Date:	Description:
	1		
	2		
	3		
	4		
	5		

Engineer:
SHANE R. HAMILTON, PE
FLORIDA LICENSE #75420

TO THE BEST OF THE ENGINEER'S KNOWLEDGE, THE PLANS AND SPECIFICATIONS COMPLY WITH THE MINIMUM BUILDING CODES. THIS DOCUMENT IS VALID FOR 12 MONTHS FROM DATE OF ENGINEER'S SIGNATURE AND SEAL. HILL ENGINEERING GROUP, INC. RESERVES ALL INTELLECTUAL AND PHYSICAL RIGHTS TO THIS DOCUMENT AND ITS CONTENTS AND PROHIBITS PUBLISHING, DISCLOSURE OR REPRODUCTION WITHOUT CONSENT.

Consultant:
Engineering Professionals, Inc.
Mechanical Engineering
912 W. Dr. Martin Luther King Jr. Blvd.
Tampa, FL 33603 (813) 251-6648

Project Name:
**ITS GENERATOR REPLACEMENT DESIGN
HIGHWAY 301 SERVICE**

Sheet Title:
FUEL GAS SITE PLAN

Project No.: 2010D
Issue Date: 04/22/2021
Drawn By: ES
Checked By: SRH
Sheet No.: